



EQUIPMENT KEY

- 1 - TIRE CLEANER
- 2 - WAX
- 3 - PRE-SOAK
- 4 - FOAM BRUSH
- 5 - SOAP
- 6 - FILTER
- 7 - CARBON FILTER
- 8 - 300 GAL. STORAGE TANK
- 9 - HEATER
- 10 - AIR COMPRESSOR
- 11 - CHEMICAL TANK (SOAP)
- 12 - SSA AUTOMATIC (WAX)

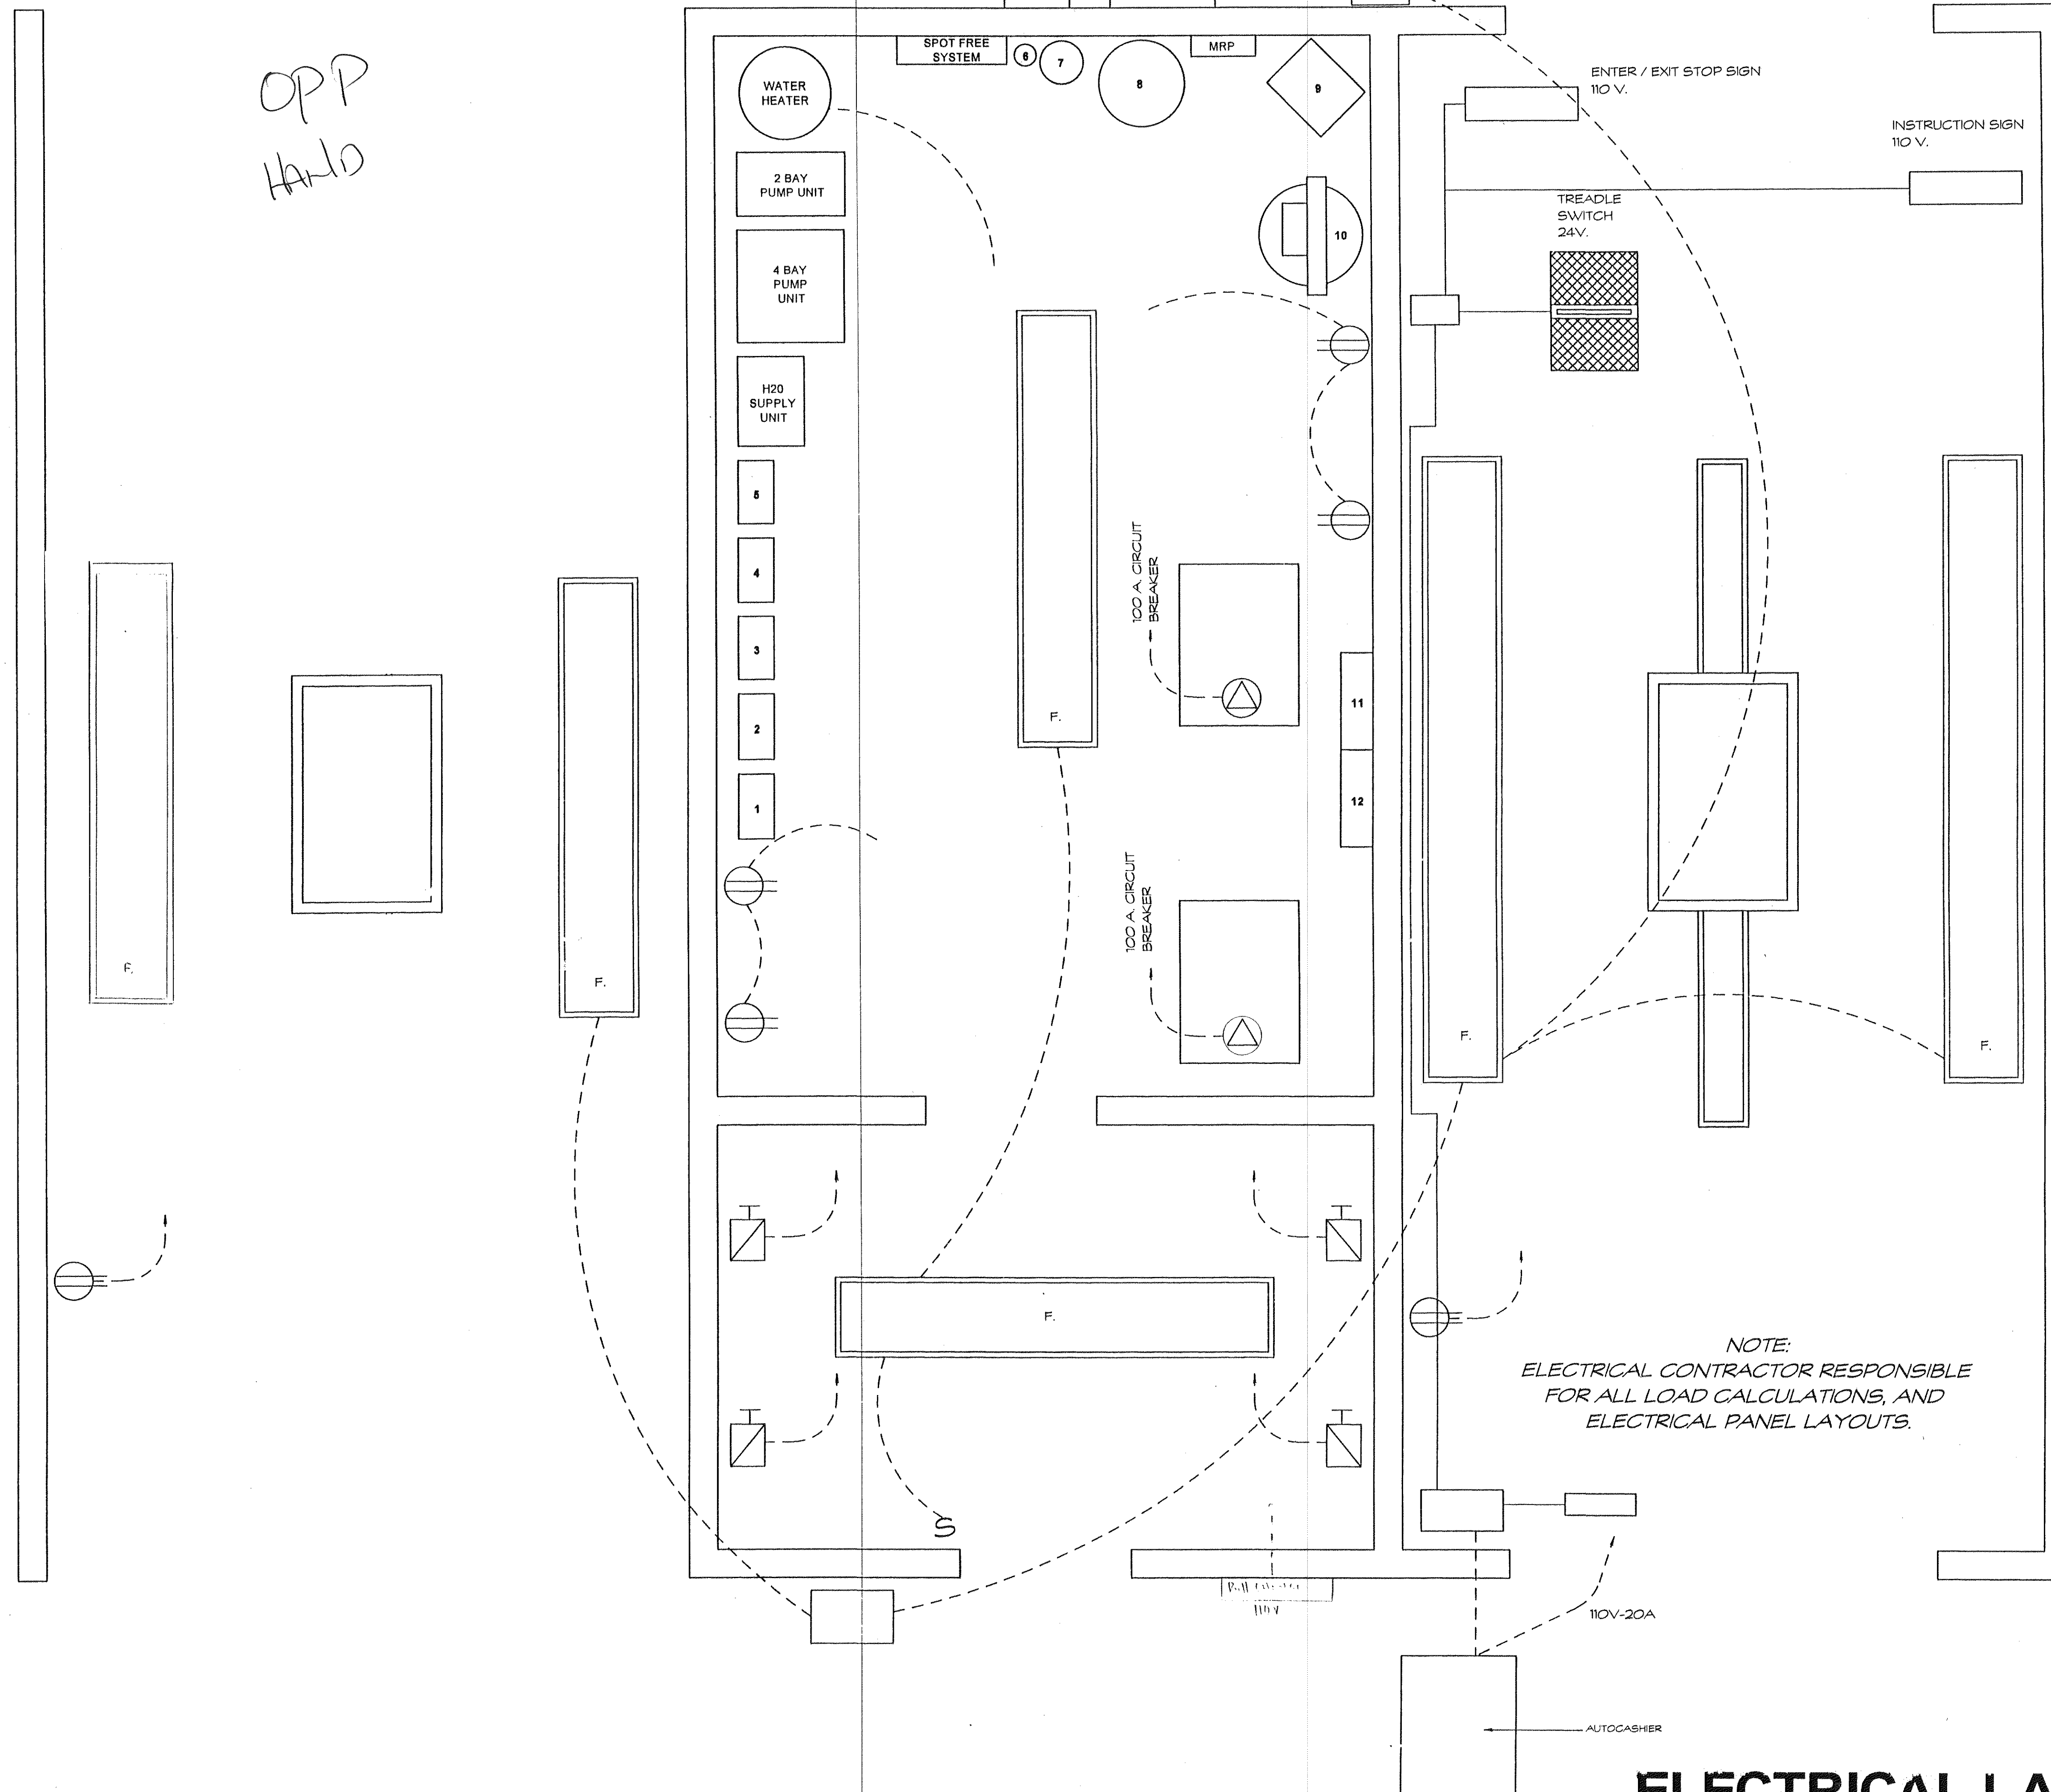

ELECTRICAL LAYOUT

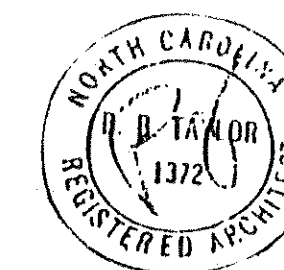

Quality by Design
Computer-Aided Architectural
and Commercial Drafting

50 EAST MAIN STREET, SUITE 114 THOMASVILLE, NC 27360
(336) 472-9430 FAX (336) 472-0178 E-MAIL: draftplan@aol.com

ELECTRICAL
LAYOUT

PROPERTY OF

CAR WASH CONCEPTS

50 East Main Street
Thomasville, NC 27360

(800) 733-9760

(336) 475-0522

DATE 2/3/98

DRAWN BY: DAF

SCALE: AS NOTED

REVISED:

APPROVED:

Sheet No.

CWC 6